



**THE CORPORATION OF THE CITY OF WINDSOR
OFFICE OF THE CITY SOLICITOR**

ALEX VUCINIC

Manager of Purchasing

Elaine Castellan

Purchasing Supervisor

(519) 255-6272

TELEPHONE NUMBER

**ADDENDUM NO. 1
TENDER NO. 166-18
DIESEL & MCC UPGRADES AT LOU ROMANO WATER RECLAMATION PLANT**

October 11, 2018

This addendum amends and forms part of the Tender Documents. The bidder shall insert the addendum behind the cover page of the Tender Documents.

REVISED DRAWINGS:

Refer to Electrical Drawings E8 Rev 4 and E12 Rev 4 (attached)

Add 150A breaker for future drainage pumping system (by others).

Except for the contents of this addendum, all other terms and conditions of this tender remain the same.

END OF ADDENDUM NO. 1

Yours truly,

THE CORPORATION OF THE CITY OF WINDSOR

Elaine Castellan

Elaine Castellan
Purchasing Supervisor

EC/jm

**ADDENDUM NO. 1
TENDER NO. 166-18
DIESEL & MCC UPGRADES AT LOU ROMANO WATER RECLAMATION PLANT**

October 11, 2018

I hereby acknowledge receipt of Addendum No. 1 to the Tender No. 166-18 (4 pages).

The information contained therein is hereby noted and account of same will be taken in our tender cost.

This information was received on the _____ day of _____, 20_____.

Signature

Name (Printed)


Company Name

***NOTE: You are required to acknowledge this addendum with your TENDER submission.**

**PLEASE FAX BACK TO (519) 255-9891 OR E-MAIL @ purchasing@citywindsor.ca SIGNED
ACKNOWLEDGEMENT SHEET ASAP**

Attn: Purchasing Department

DILLON CONSULTING LIMITED, 3200 DEZIEL DRIVE, SUITE 608, WINDSOR, ONTARIO, N8W 5K6, PHONE (519) 946-5000, FAX (519) 946-5054

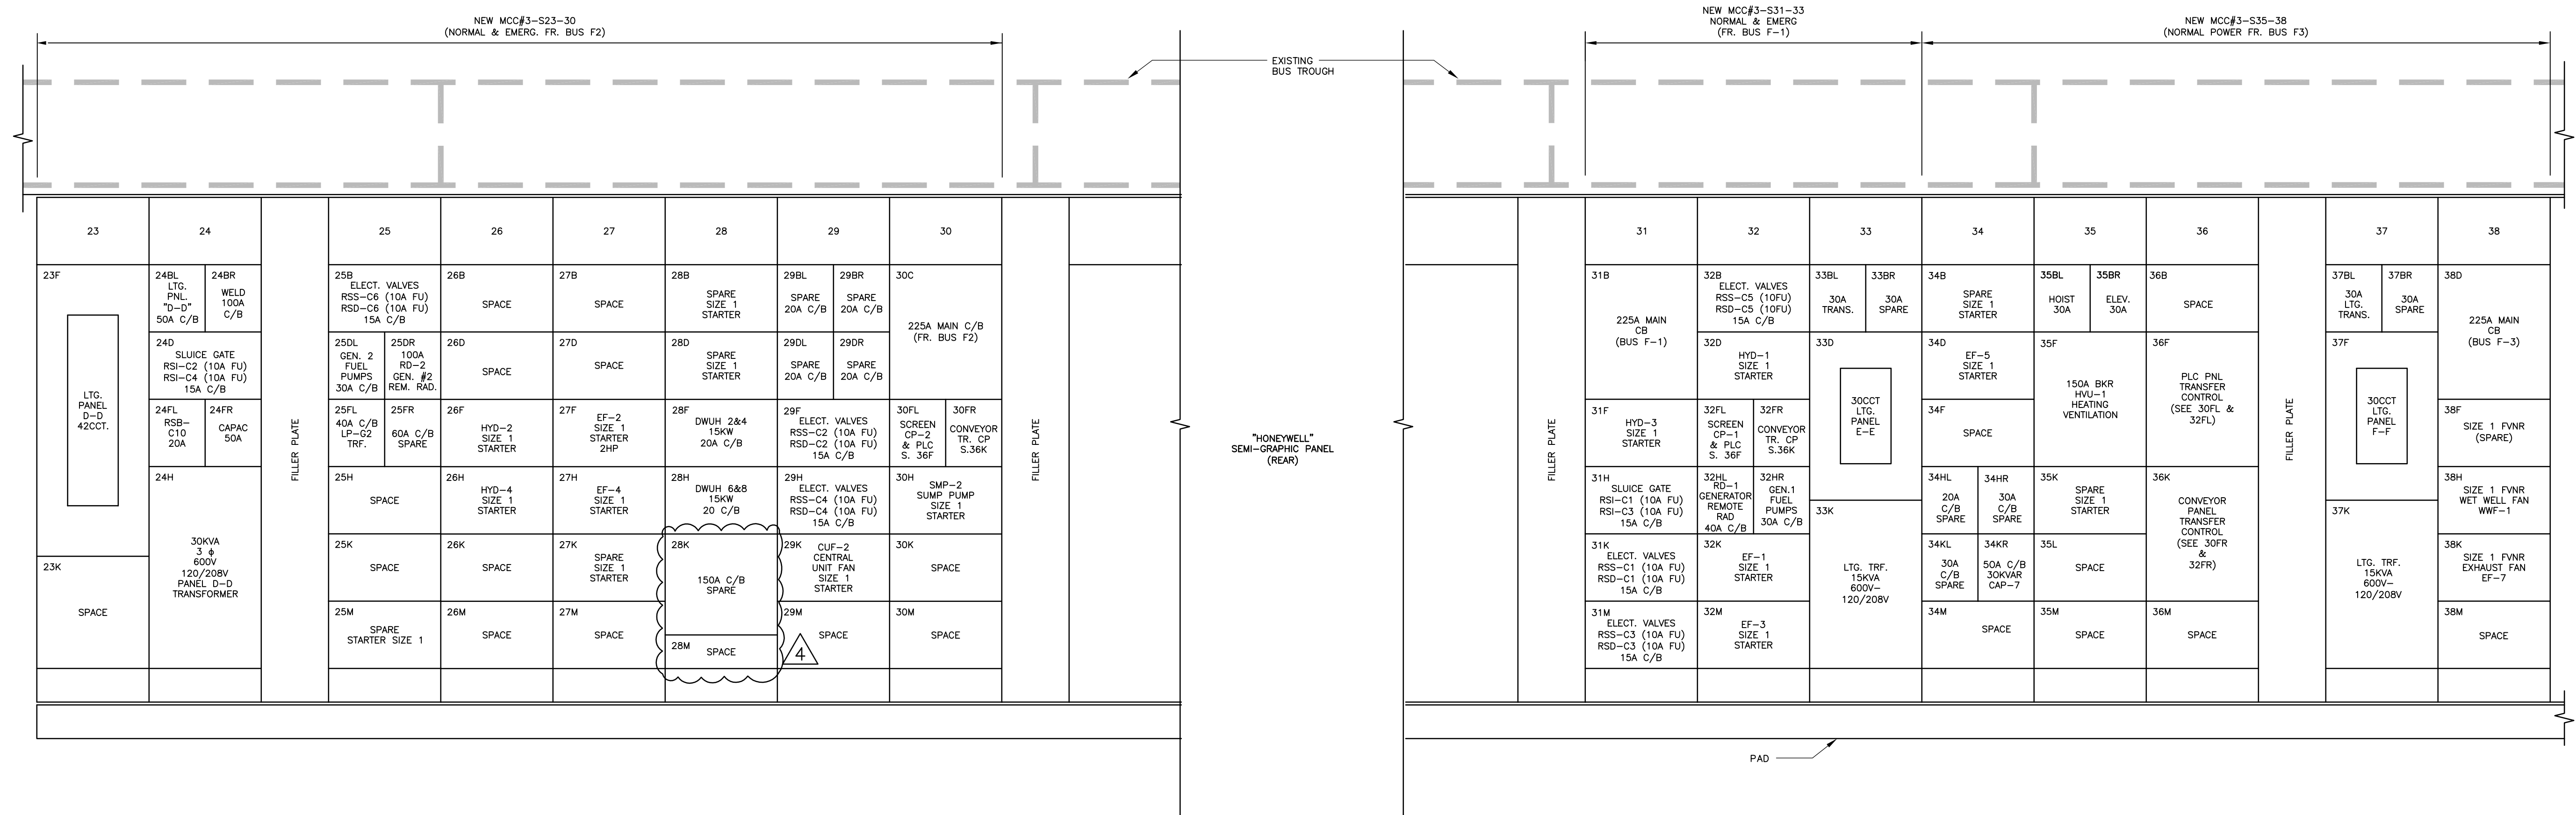

MCC No. 3 - S23-38 ELEVATION - NEW
3/4"=1'-0"

Conditions of Use
Verify elevations and/or dimensions on drawing prior to use. Report any discrepancies to Dillon Consulting Limited.
Do not scale dimensions from drawing.
Do not modify drawing, re-use it, or use it for purposes other than those intended at the time of its preparation without prior written permission from Dillon Consulting Limited.



TENDER No. 166-18

NOT FOR CONSTRUCTION



No.	ISSUED FOR	DATE	BY
4	ADDENDUM No. 1	2016-10-10	BLD
3	TENDER No. 166-18	2016-10-06	BLD
2	90% CLIENT REVIEW	2017-12-19	BLD
1	60% CLIENT REVIEW	2017-04-19	BLD

DESIGN	VC	REVIEWED BY	BLD
DRAWN	WC	CHECKED BY	BLD
DATE	AUGUST 2016		
SCALE	NOTED		

CITY OF WINDSOR
LOU ROMANO WRP DIESEL AND MCC UPGRADES


ELECTRICAL

NEW MCC#3 (SECTION 23-38) ELEVATION

PROJECT NO. 15-2463
SHEET NO. **E12**

DILLON CONSULTING LIMITED 3200 DEZIEL DRIVE, SUITE 608, WINDSOR, ONTARIO, N8W 5K6; PHONE (519) 946-5000; FAX (519) 946-5054

FILENAME: C:\PROJECTS\WORKING DIRECTORY\ACTIVE\SYNCH\DRAWING\15-2463-04-ELEC-COM-LOU ROMANO.DWG
PLOT DATE: 2018-10-10 @ 8:15:25 AM PLOT SCALE: 1:1 PLOT STYLE: DILLON-STD.ACT

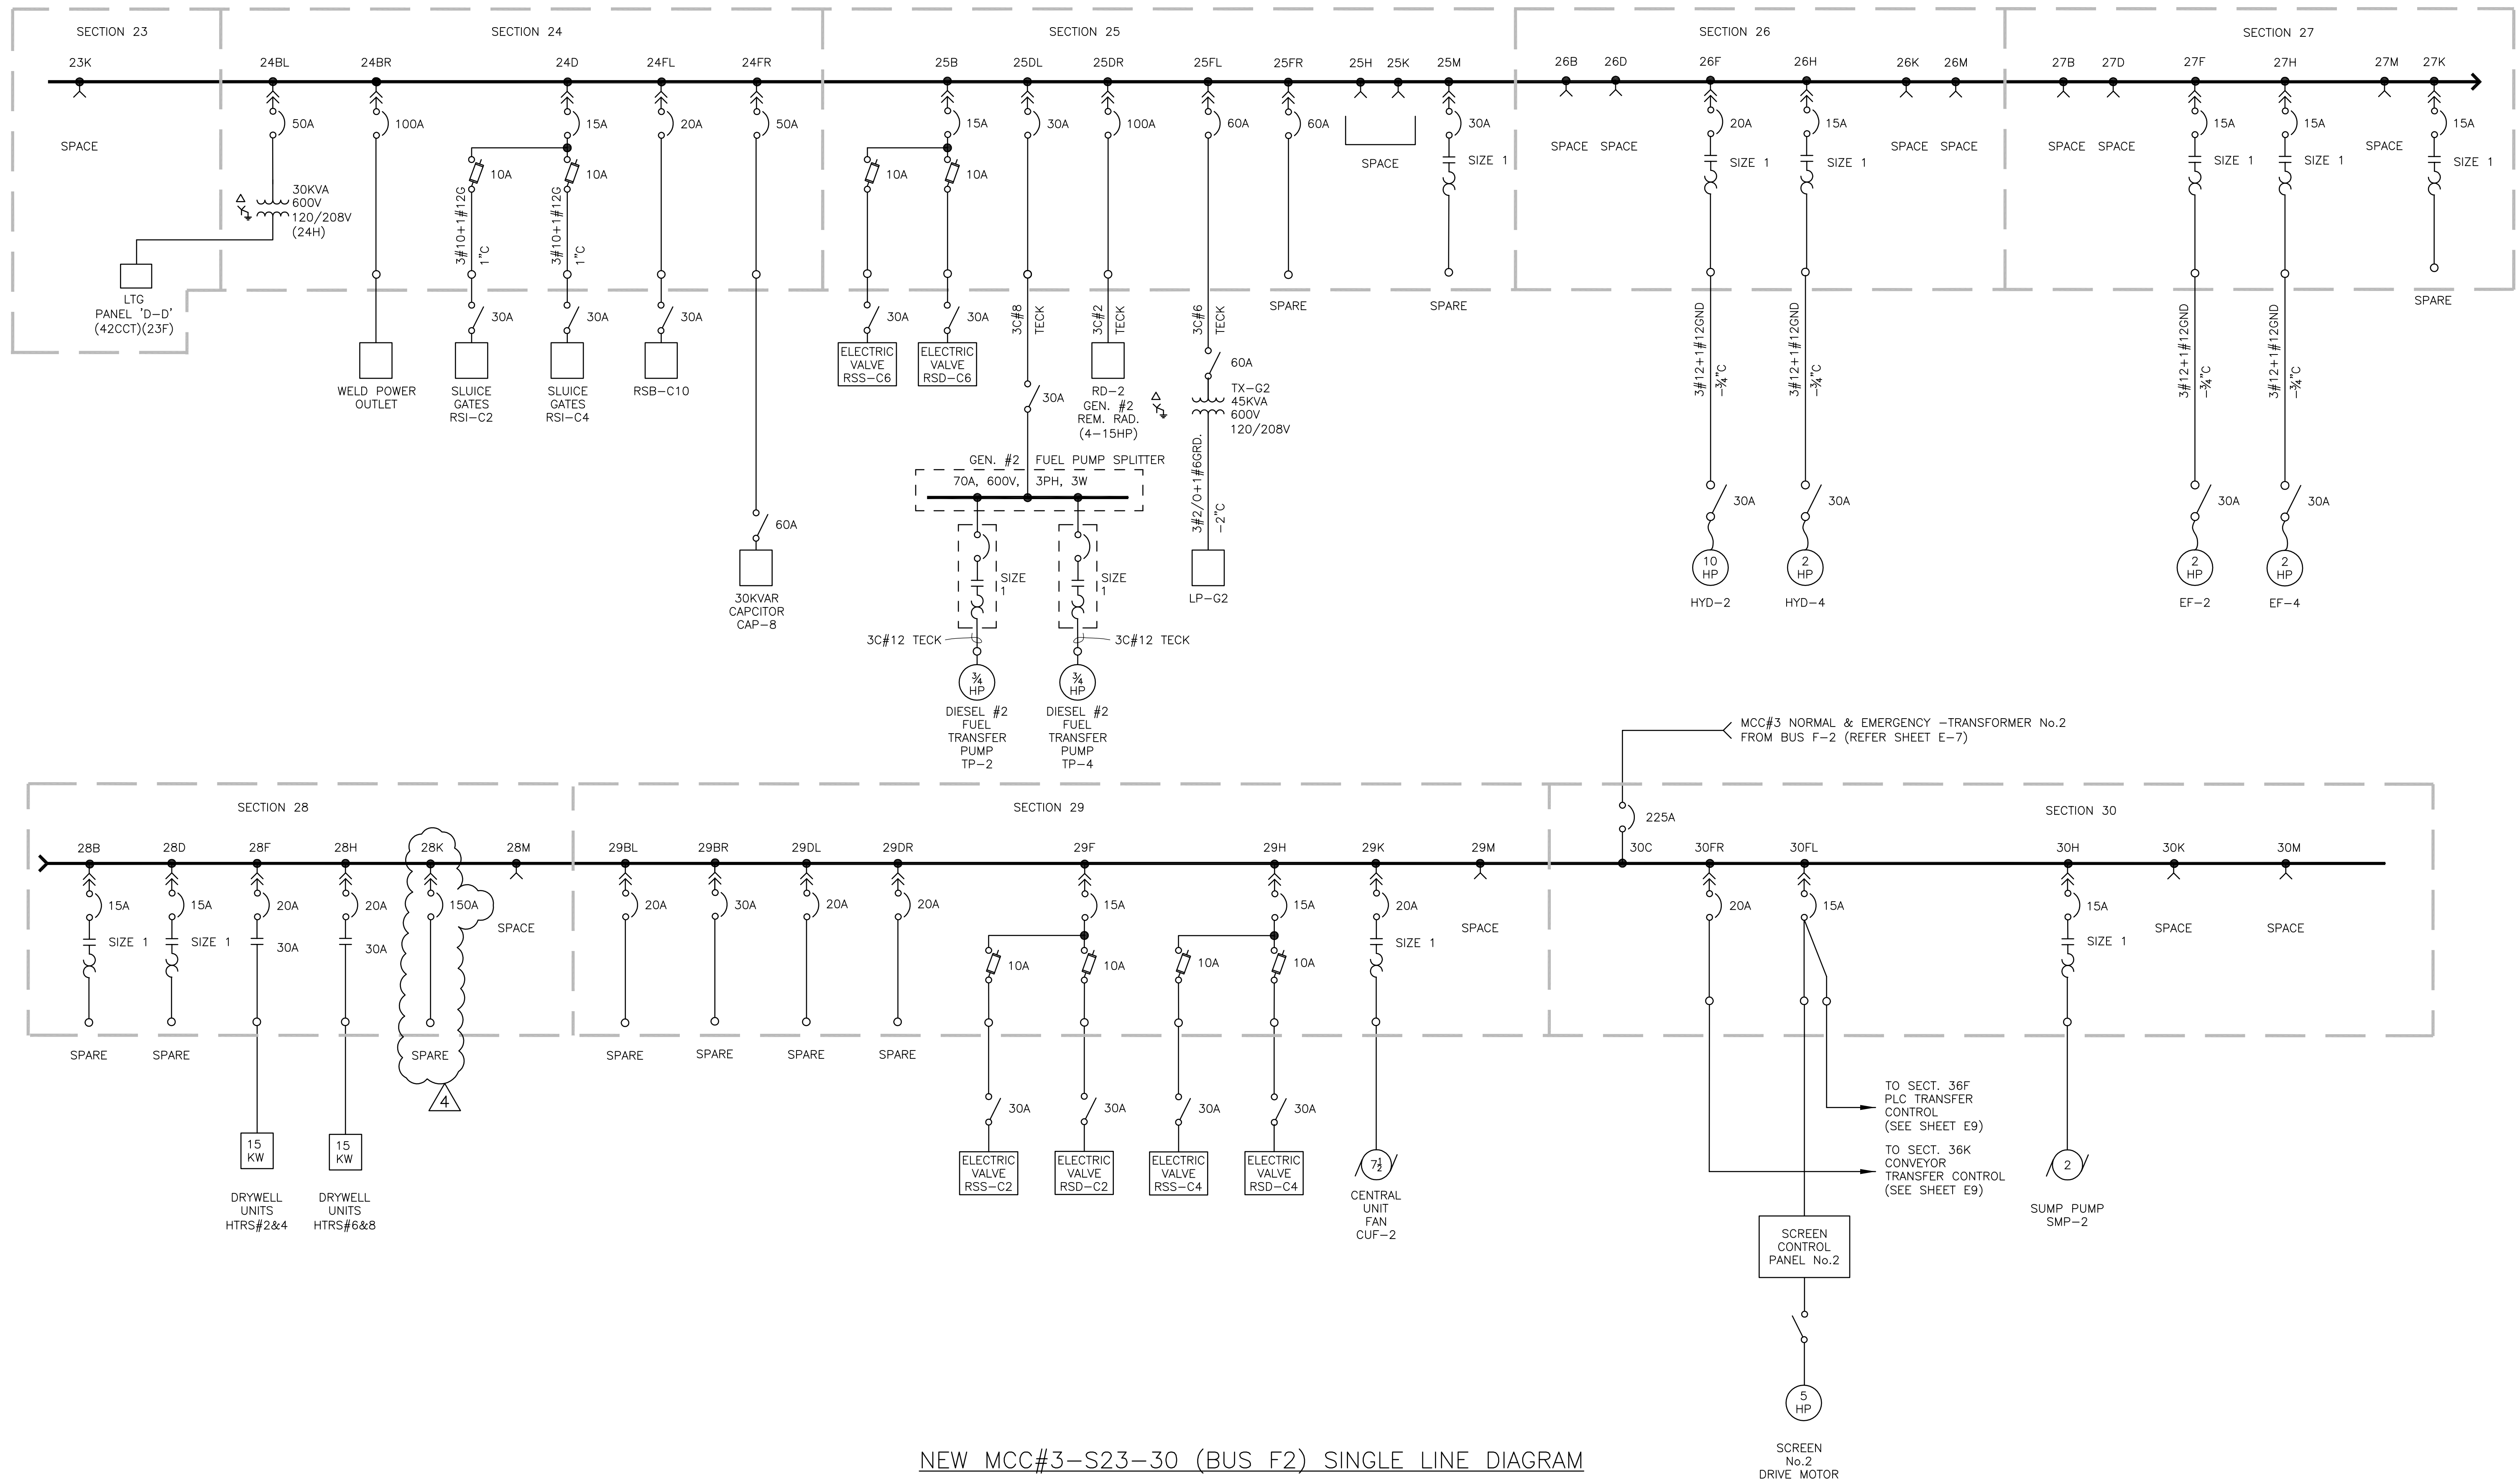

NEW MCC#3-S23-30 (BUS F2) SINGLE LINE DIAGRAM

Conditions of Use
 Verify elevations and/or dimensions on drawing prior to use. Report any discrepancies to Dillon Consulting Limited.
 Do not scale dimensions from drawing.
 Do not modify drawing, re-use it, or use it for purposes other than those intended at the time of its preparation without prior written permission from Dillon Consulting Limited.



TENDER No. 166-18

NOT FOR CONSTRUCTION



No.	ISSUED FOR	DATE	BY
4	ADDENDUM No. 1	2018-10-10	BLD
3	TENDER No. 166-18	2018-10-06	BLD
2	90% CLIENT REVIEW	2017-12-19	BLD
1	60% CLIENT REVIEW	2017-04-19	BLD

DESIGN	REVIEWED BY
BLD	BLD
DRAWN	CHECKED BY
WC	BLD
DATE	MAR. 2017
SCALE	N.T.S.

CITY OF WINDSOR
LOU ROMANO WRP DIESEL AND MCC UPGRADES

ELECTRICAL
NEW MCC#3-S23-30 (BUS F2)
SINGLE LINE DIAGRAM

PROJECT NO. 15-2463
 SHEET NO. **E8**